


 
27 JUN 1981

0374_3465

5 cm

05BH05 3004

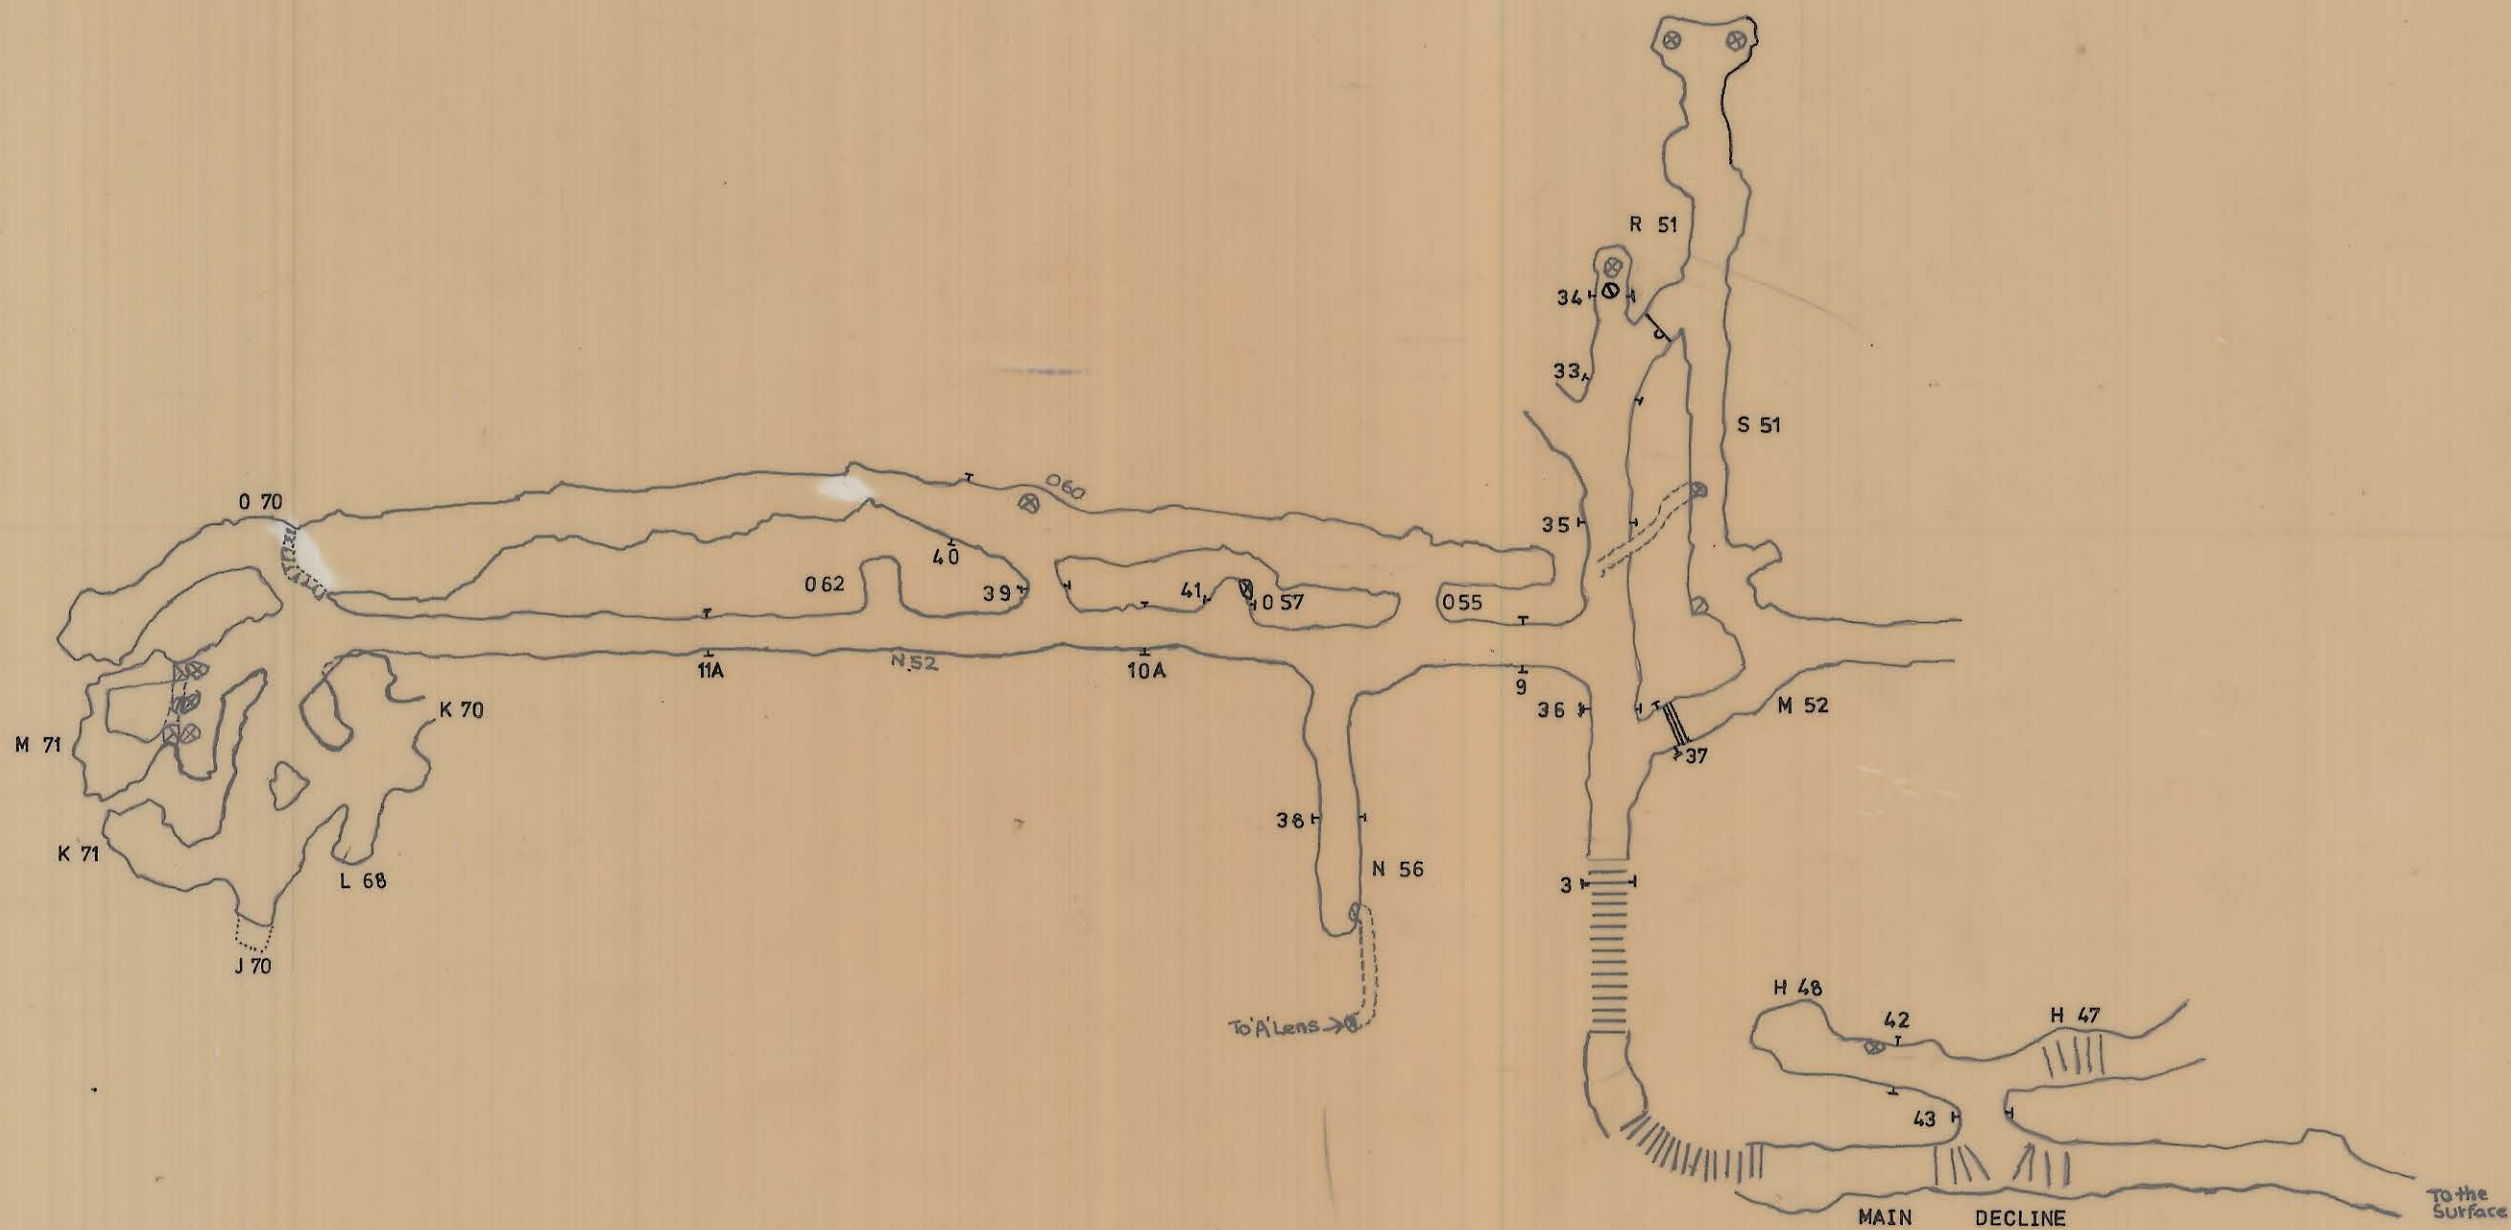

	KING ISLAND SCHEELITE LTD.	
	SCALE 1:1000	05BH05 3004
	BOLD HEAD MINE UPPER B LENS	
	VENTILATION PLAN	
	DATE	
SURVEYED		
DRAWN		
TRACED		
CHECKED		