


27 JUN 1981

0374_3468

05BH05 3005

5 cm

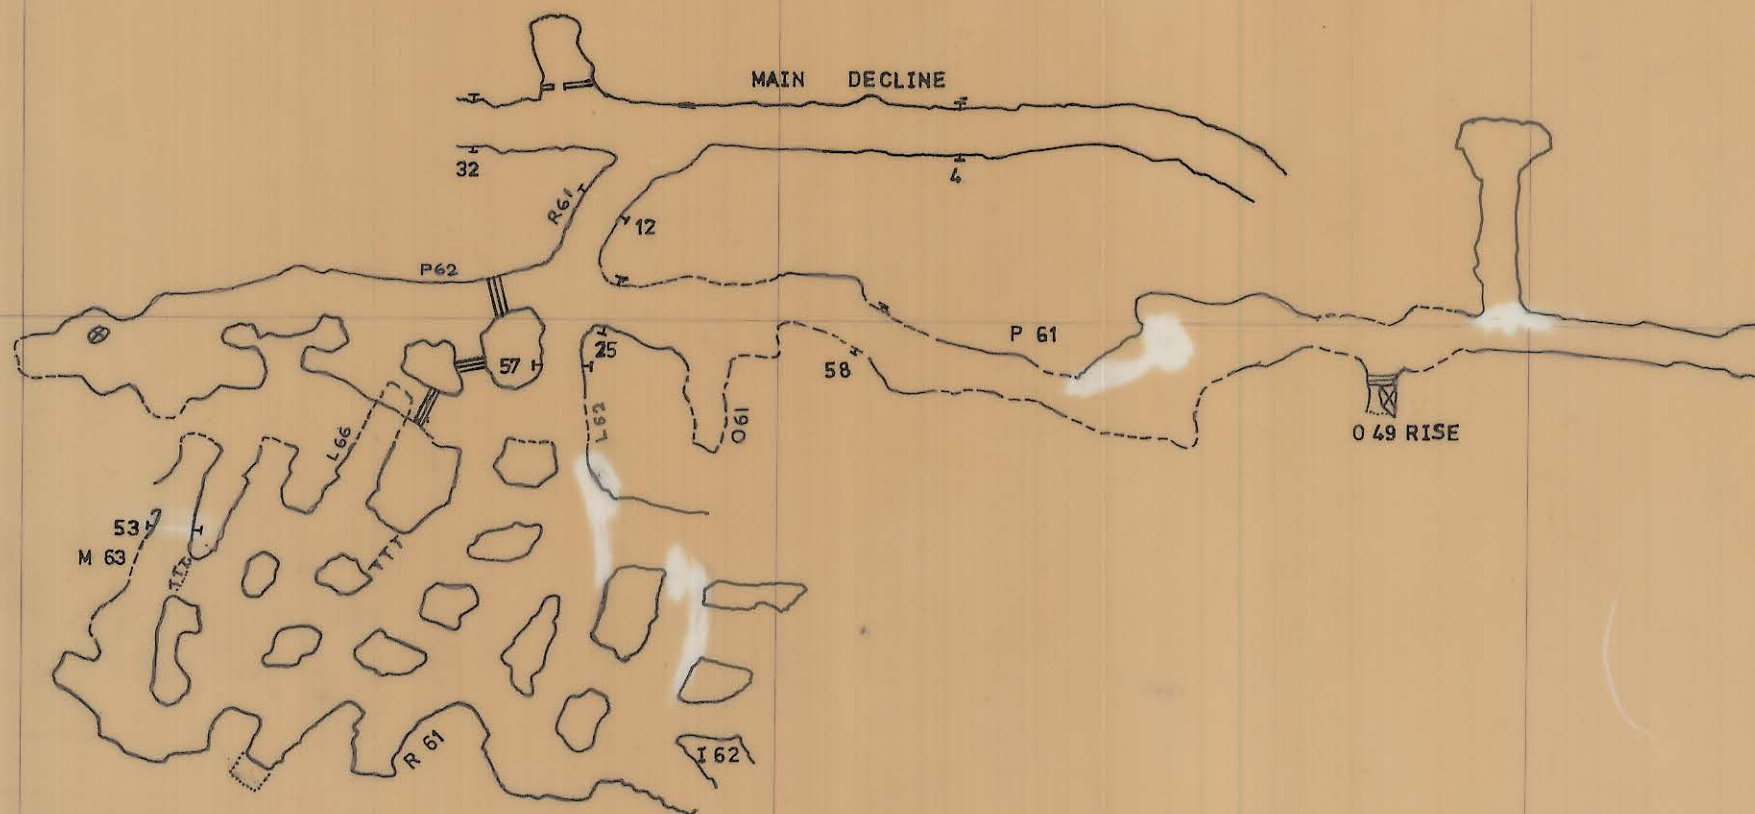

KING ISLAND SCHEELITE LTD.

SCALE 1:1000

05BH05 3005

DATE
SURVEYED
DRAWN
TRACED
CHECKED

BOLD HEAD MINE
MAIN 'B' LENS 1000 LEVEL

VENTILATION PLAN