
 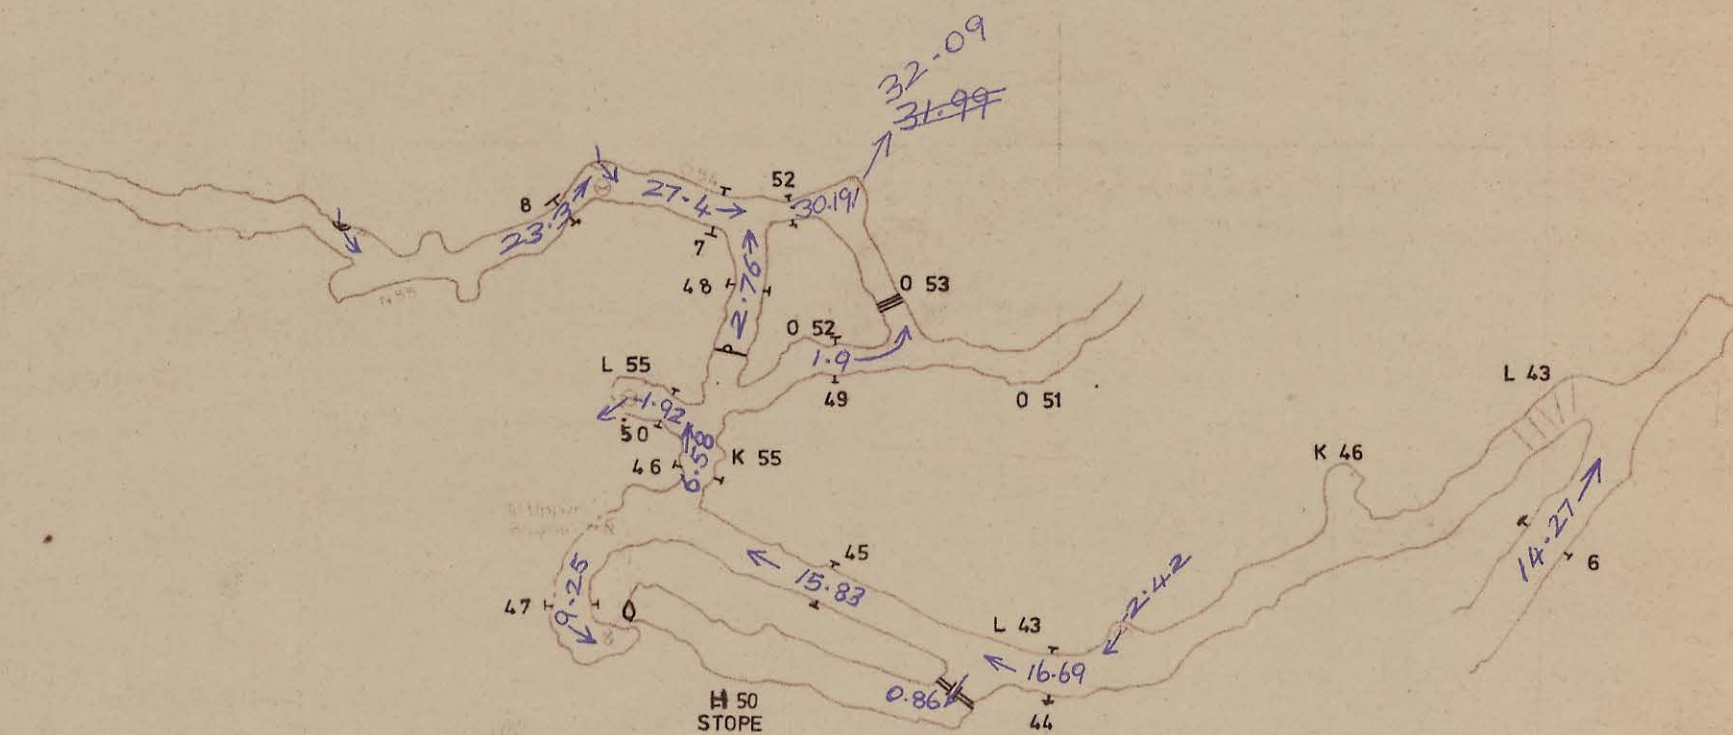


0374_3505

5 cm

05BH05 3023



	KING ISLAND SCHEELITE LTD.	
	SCALE 1:1000	05BH05 3023
	BOLD HEAD MINE A LENS	
	VENTILATION PLAN	
	DATE SURVEYED DRAWN TRACED CHECKED	