


0374_3507

5 cm

05BH05 3025

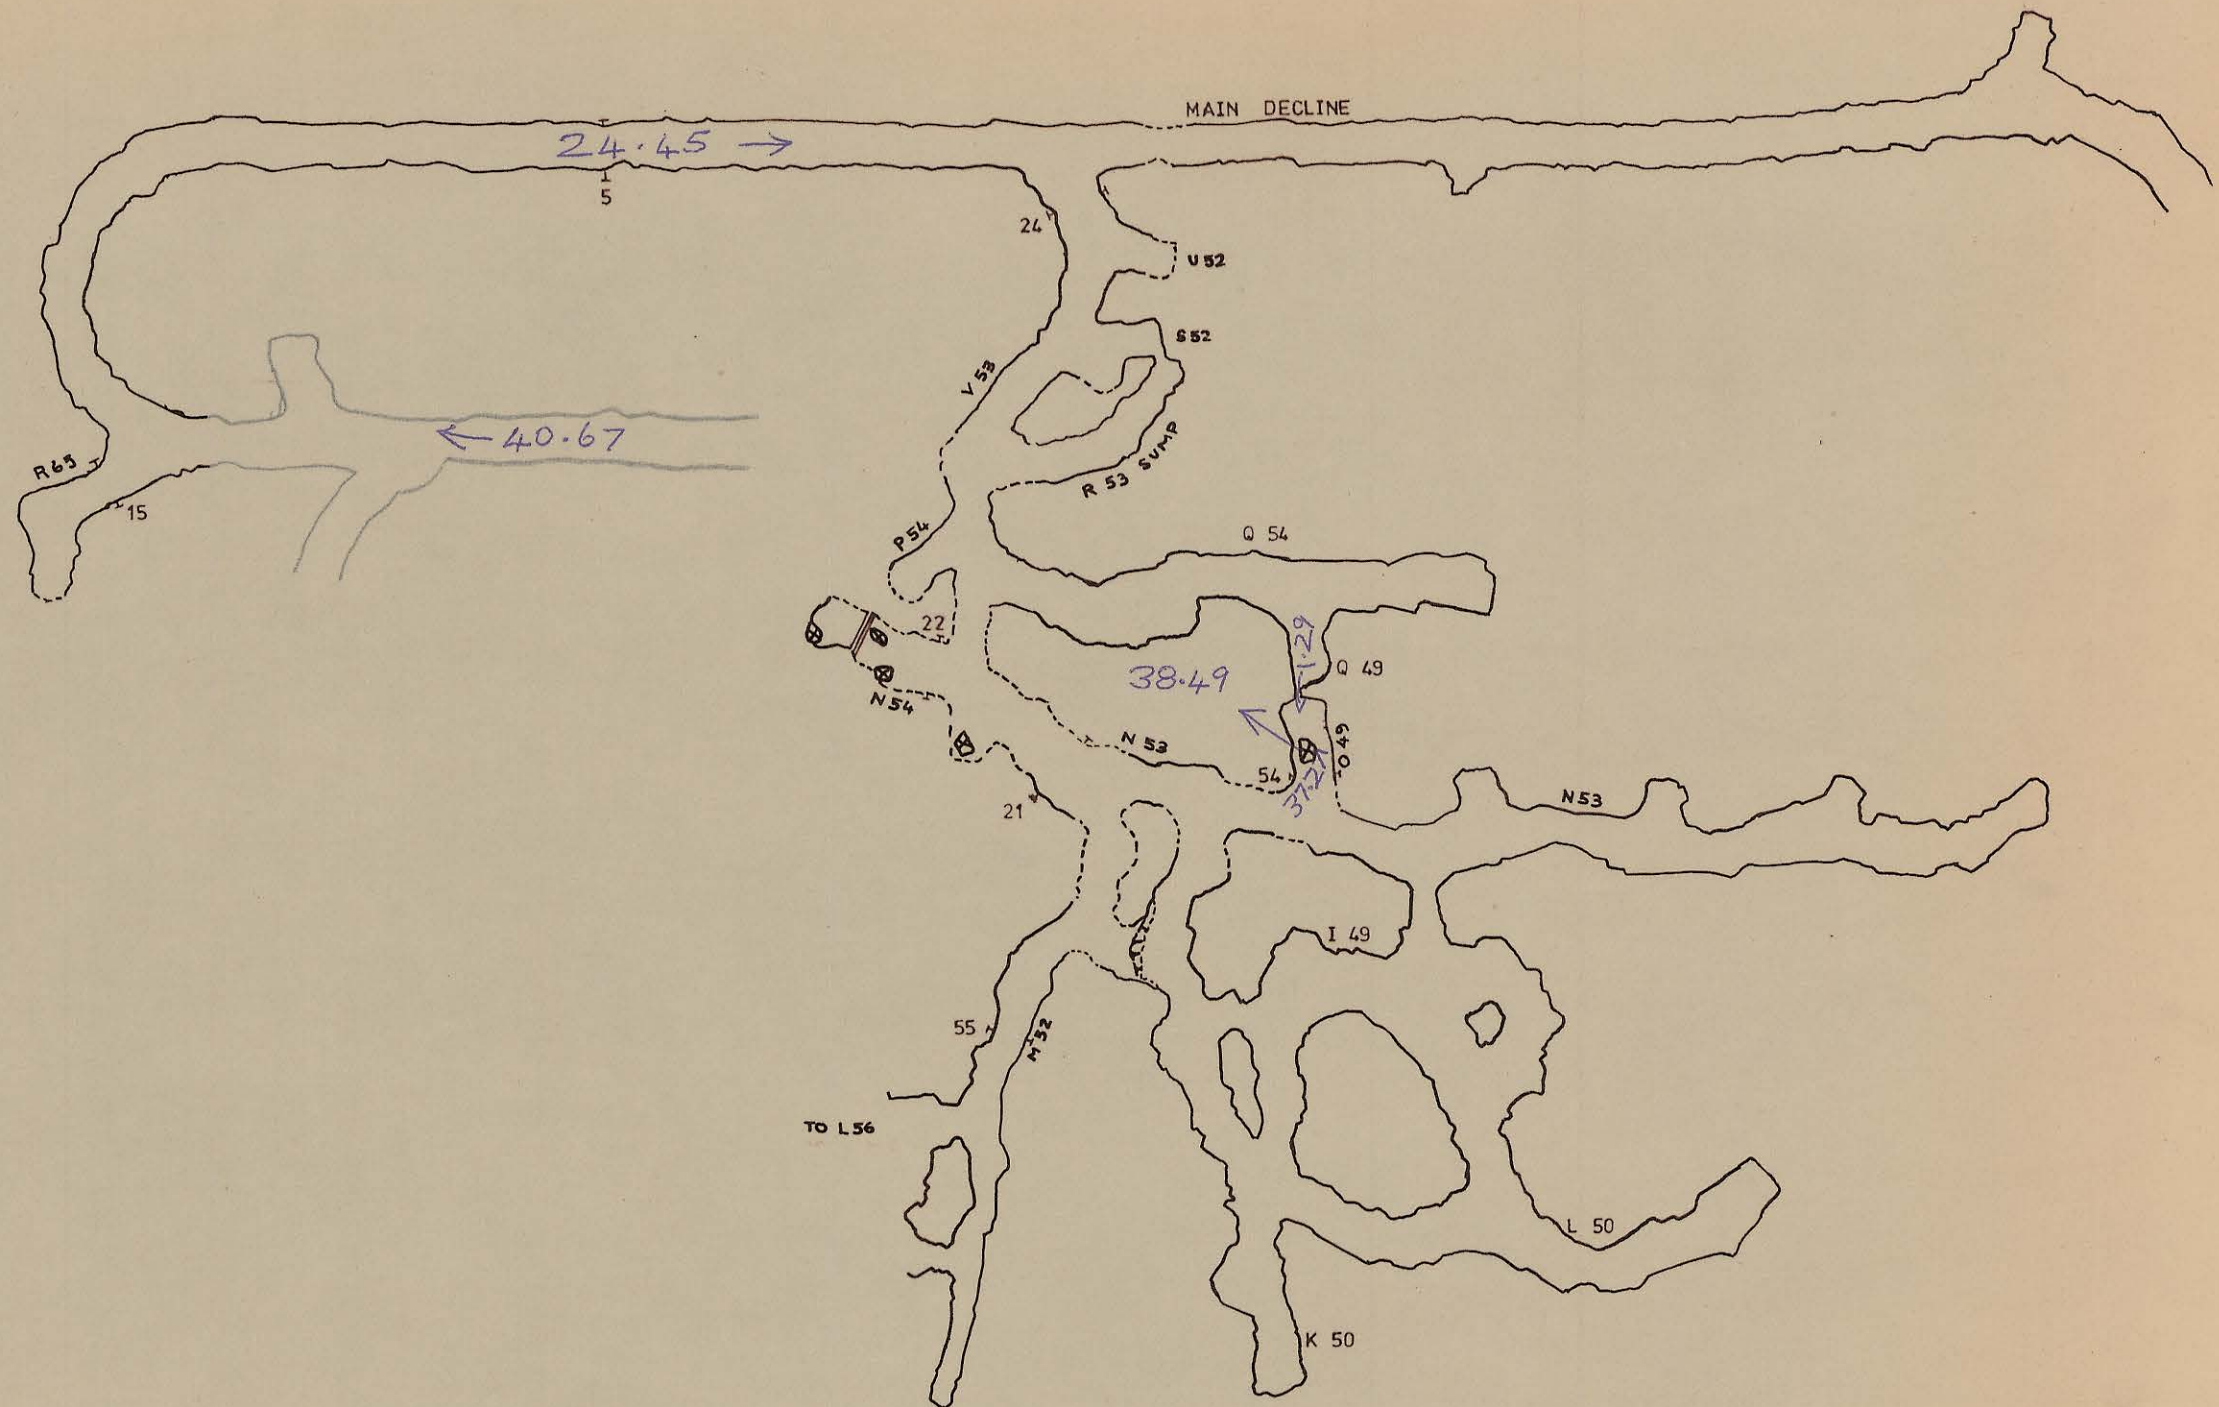

	KING ISLAND SCHEELITE LTD.	
	SCALE 1:1000	05BH05 3025
	BOLD HEAD MINE R LENS FAULT BLOCK	
	VENTILATION PLAN	