


 
0374_3510

5 cm

05BH05 3028

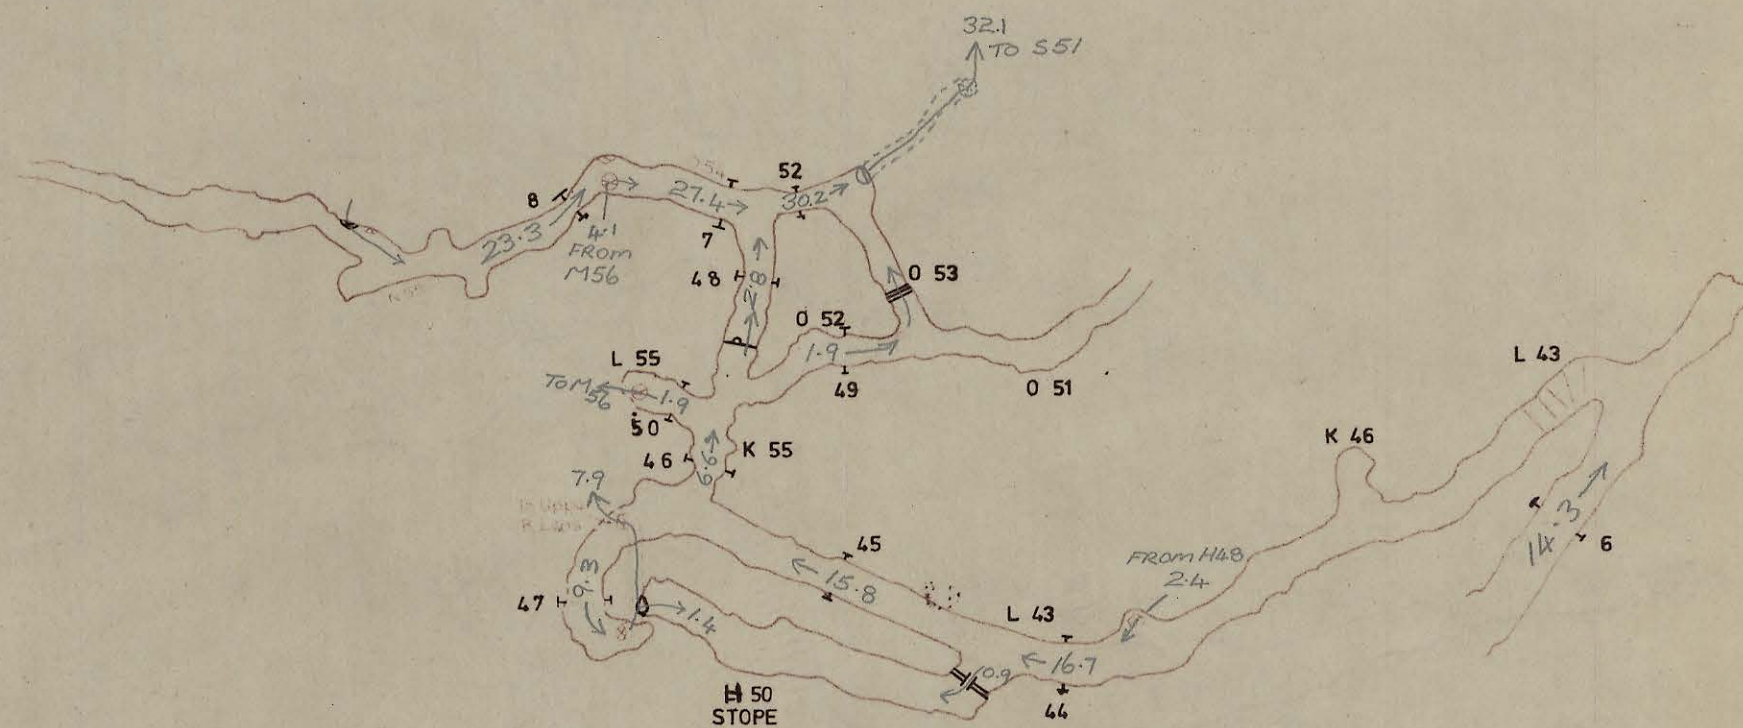

BOLD HEAD
VENTILATION SUMMARY
APRIL 1977
VOLUMES IN M³/S

	KING ISLAND SCHEELITE LTD.	
	SCALE 1:1000	05BH05 3028
	BOLD HEAD MINE A LENS	
	VENTILATION PLAN	

DATE
SURVEYED
DRAWN
TRACED
CHECKED