


0374_3511

05BH05 3029

5 cm

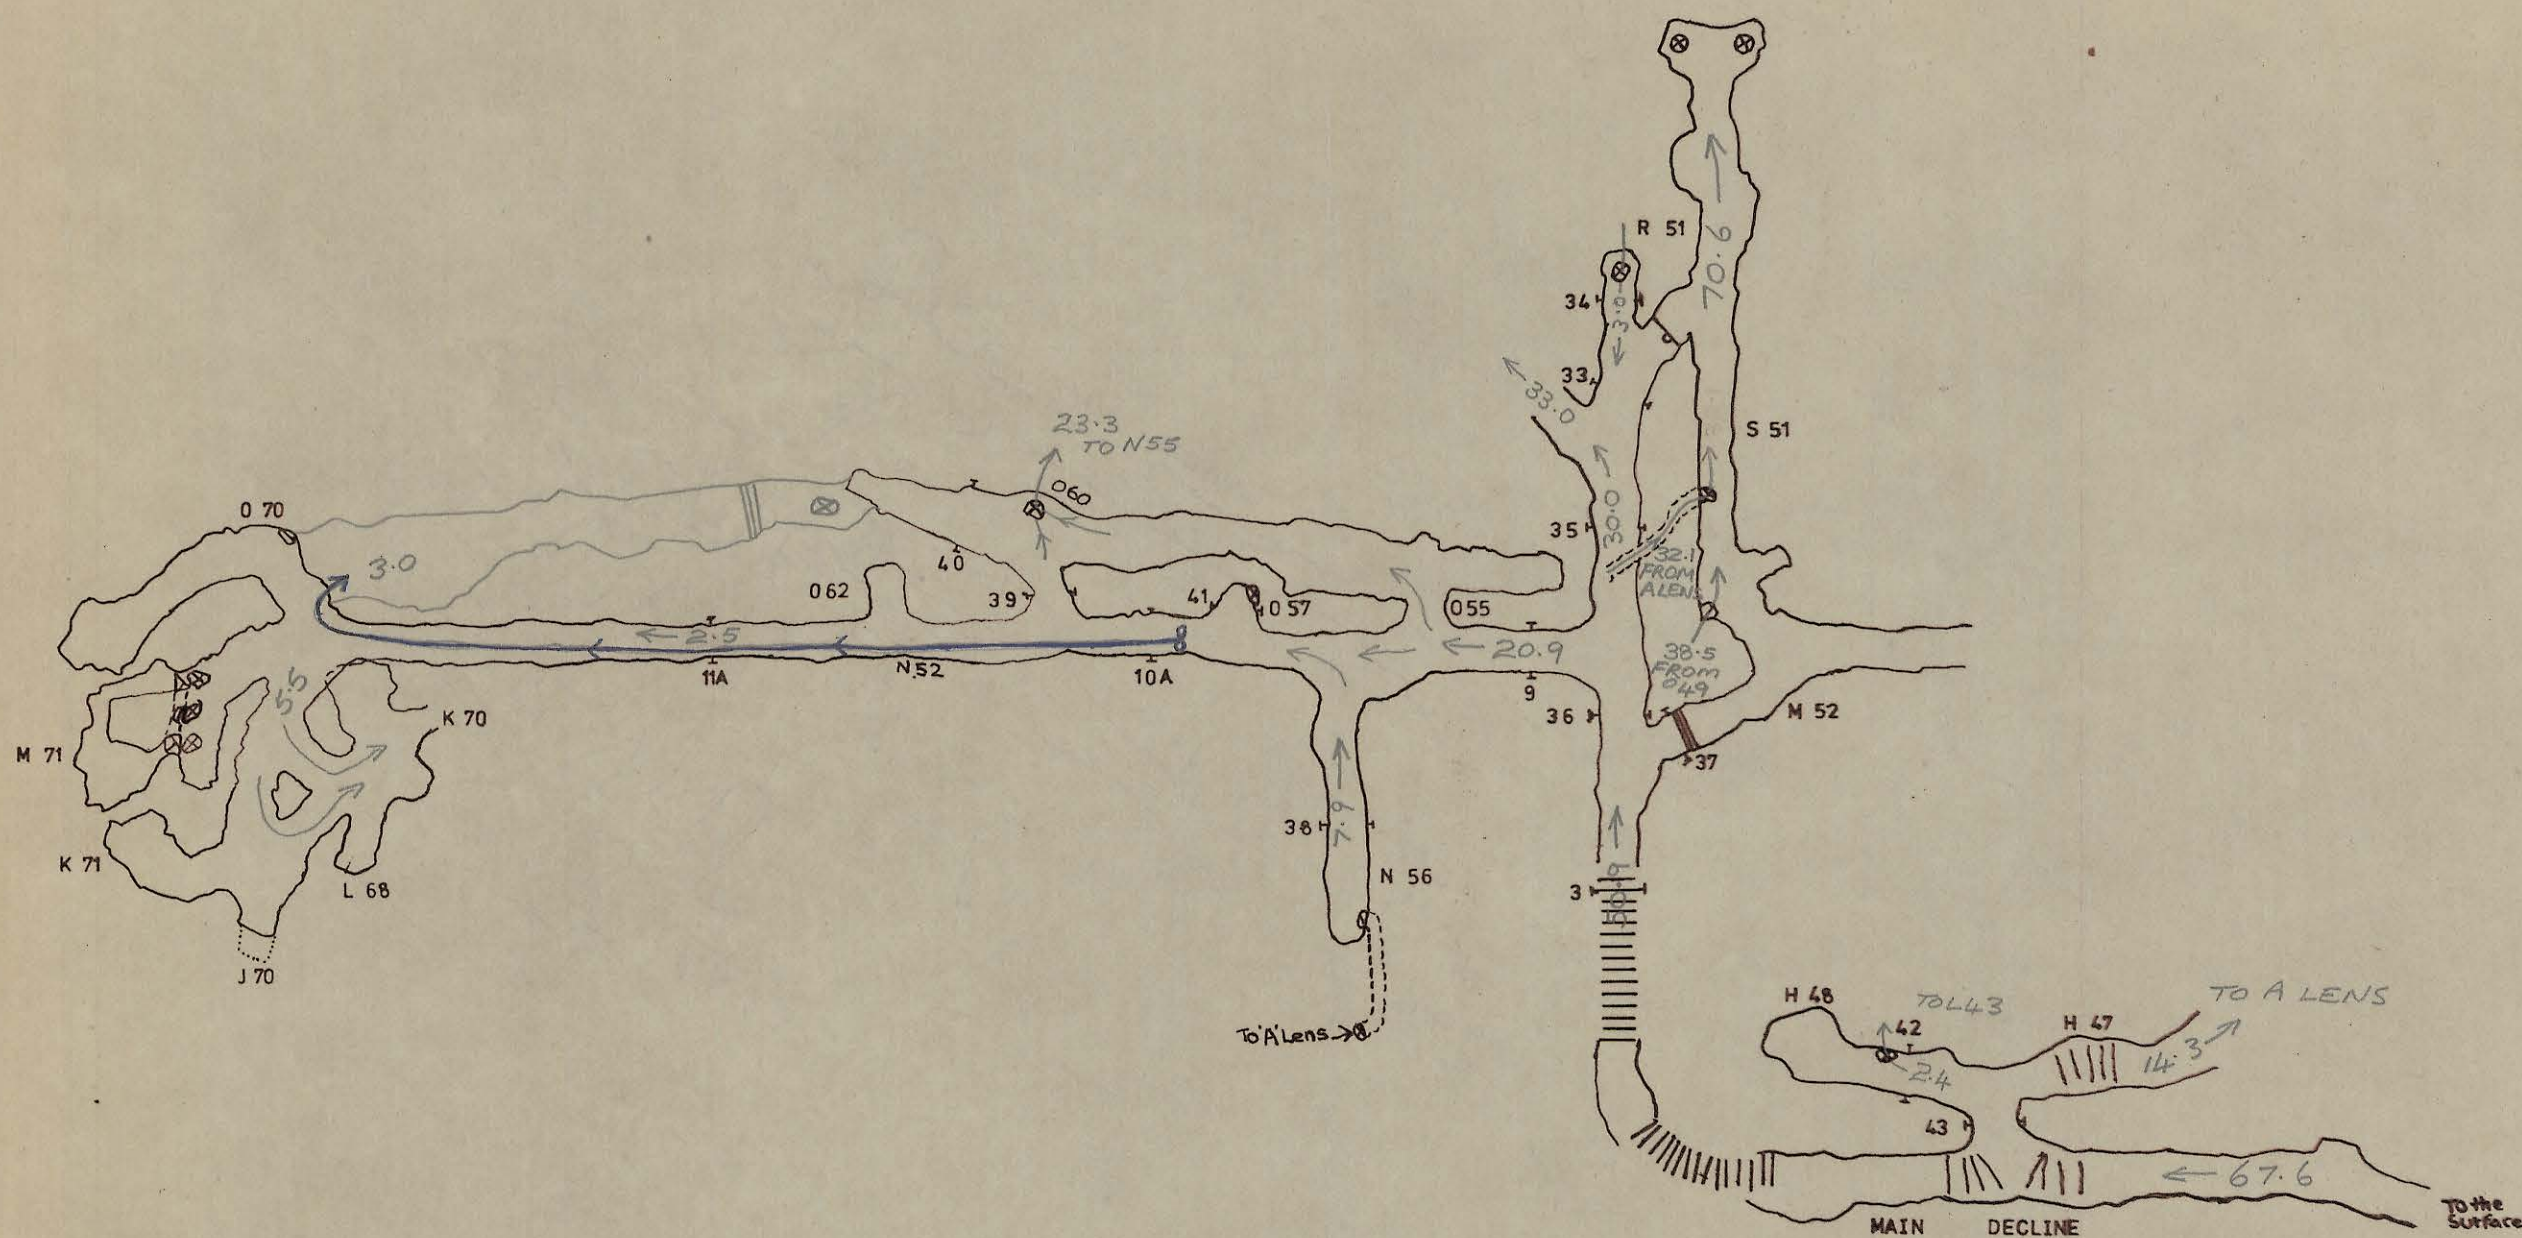

BOLD HEAD
VENTILATION SUMMARY
APRIL 1977
VOLUMES IN M³/S

K I S	KING ISLAND SCHEELITE LTD.	
	SCALE 1:1000	05BH05 3029
BOLD HEAD MINE UPPER B LENS		
VENTILATION PLAN		