


 
0374_3512

05BH05 3030

5 cm

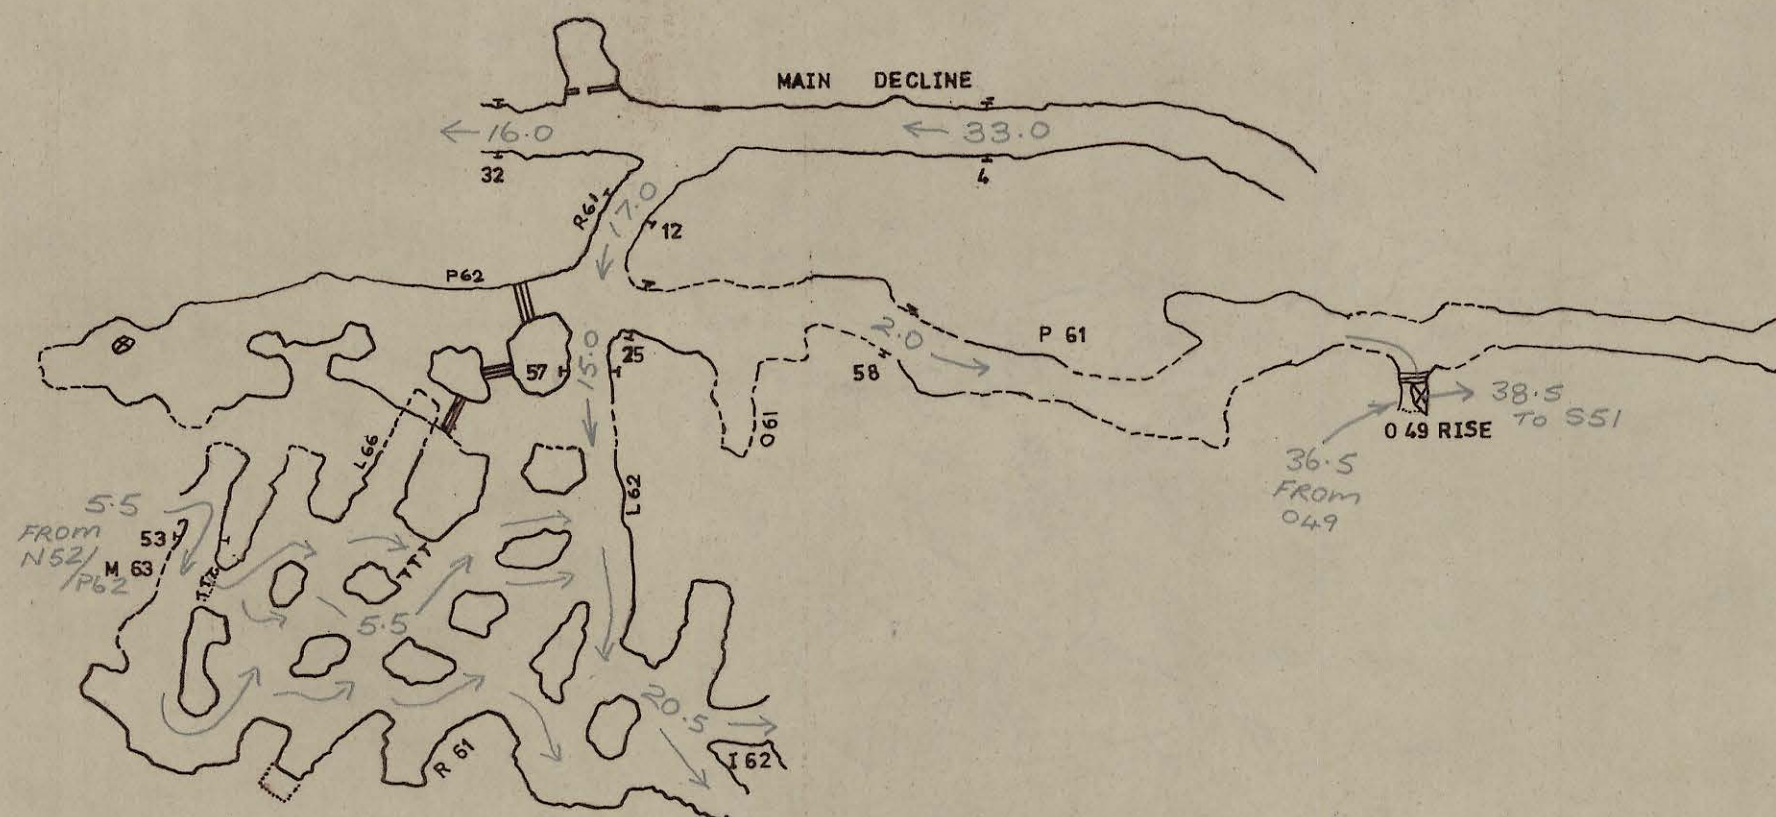

BOLD HEAD
VENTILATION SUMMARY
APRIL 1977
VOLUMES IN M³/S

	KING ISLAND SCHEELITE LTD.	
	SCALE 1:1000	05BH05 3030
	BOLD HEAD MINE MAIN B LENS 1000 LEVEL	
	VENTILATION PLAN	
DATE		
SURVEYED		
DRAWN		
TRACED		
CHECKED		