


0374_3515

5 cm

05BH05 3033

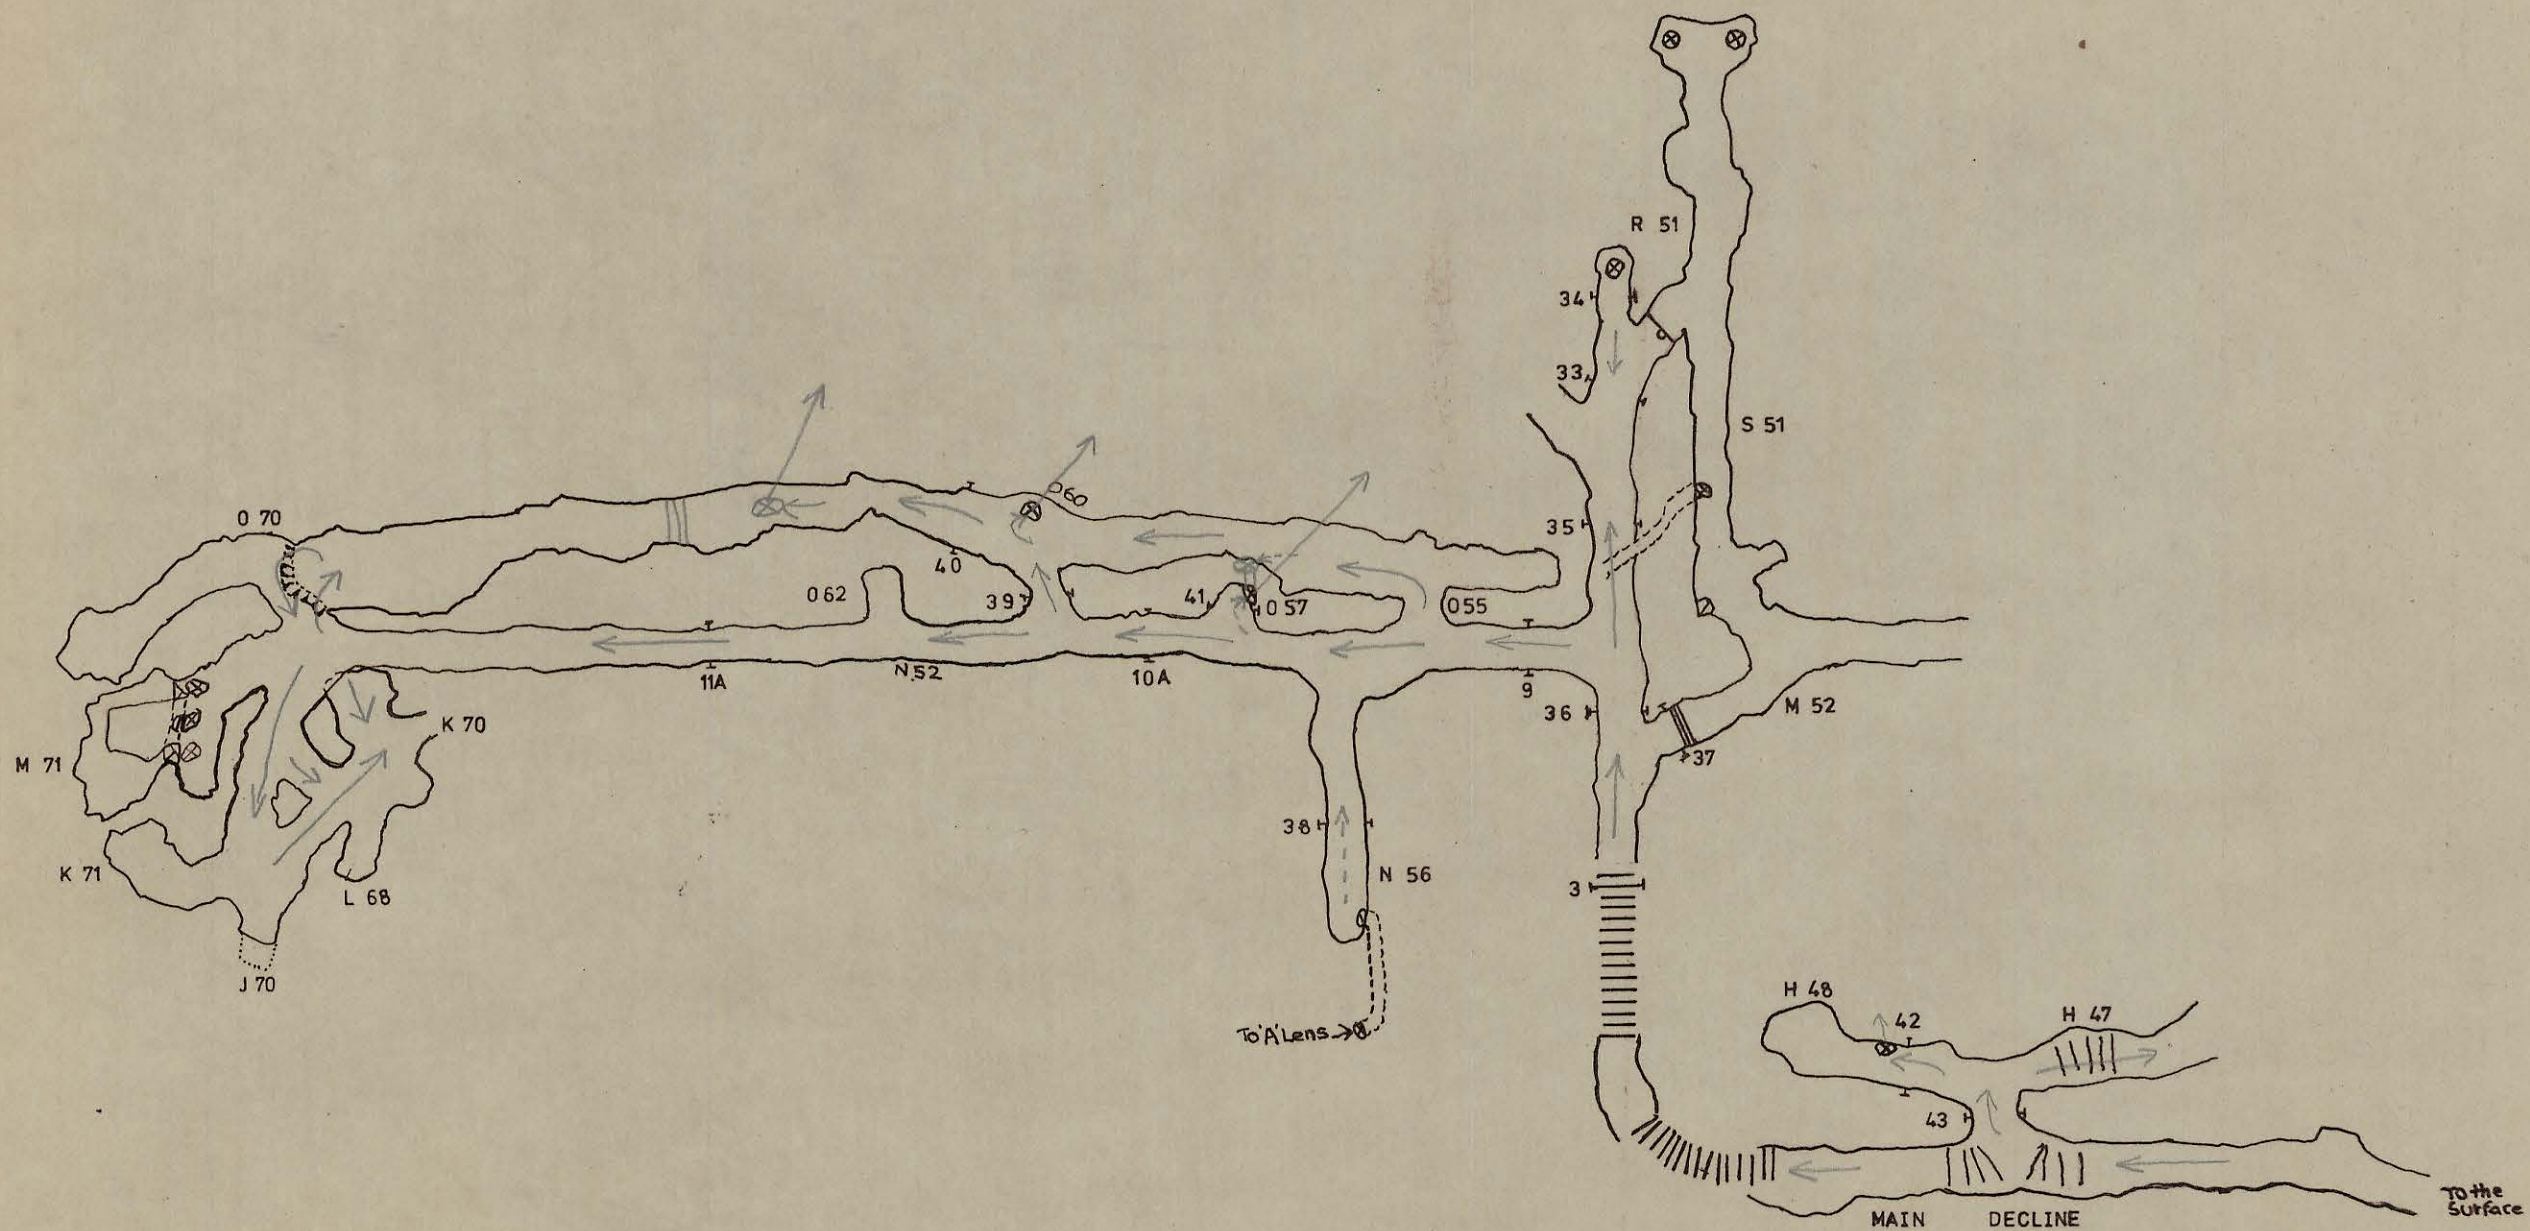

	KING ISLAND SCHEELITE LTD.	
	SCALE 1:1000	05BH05 3033
	BOLD HEAD MINE UPPER B LENS VENTILATION PLAN SMOKE TUBE SURVEY 3-6-77	