


0374_3518

5 cm

05BH05 3036

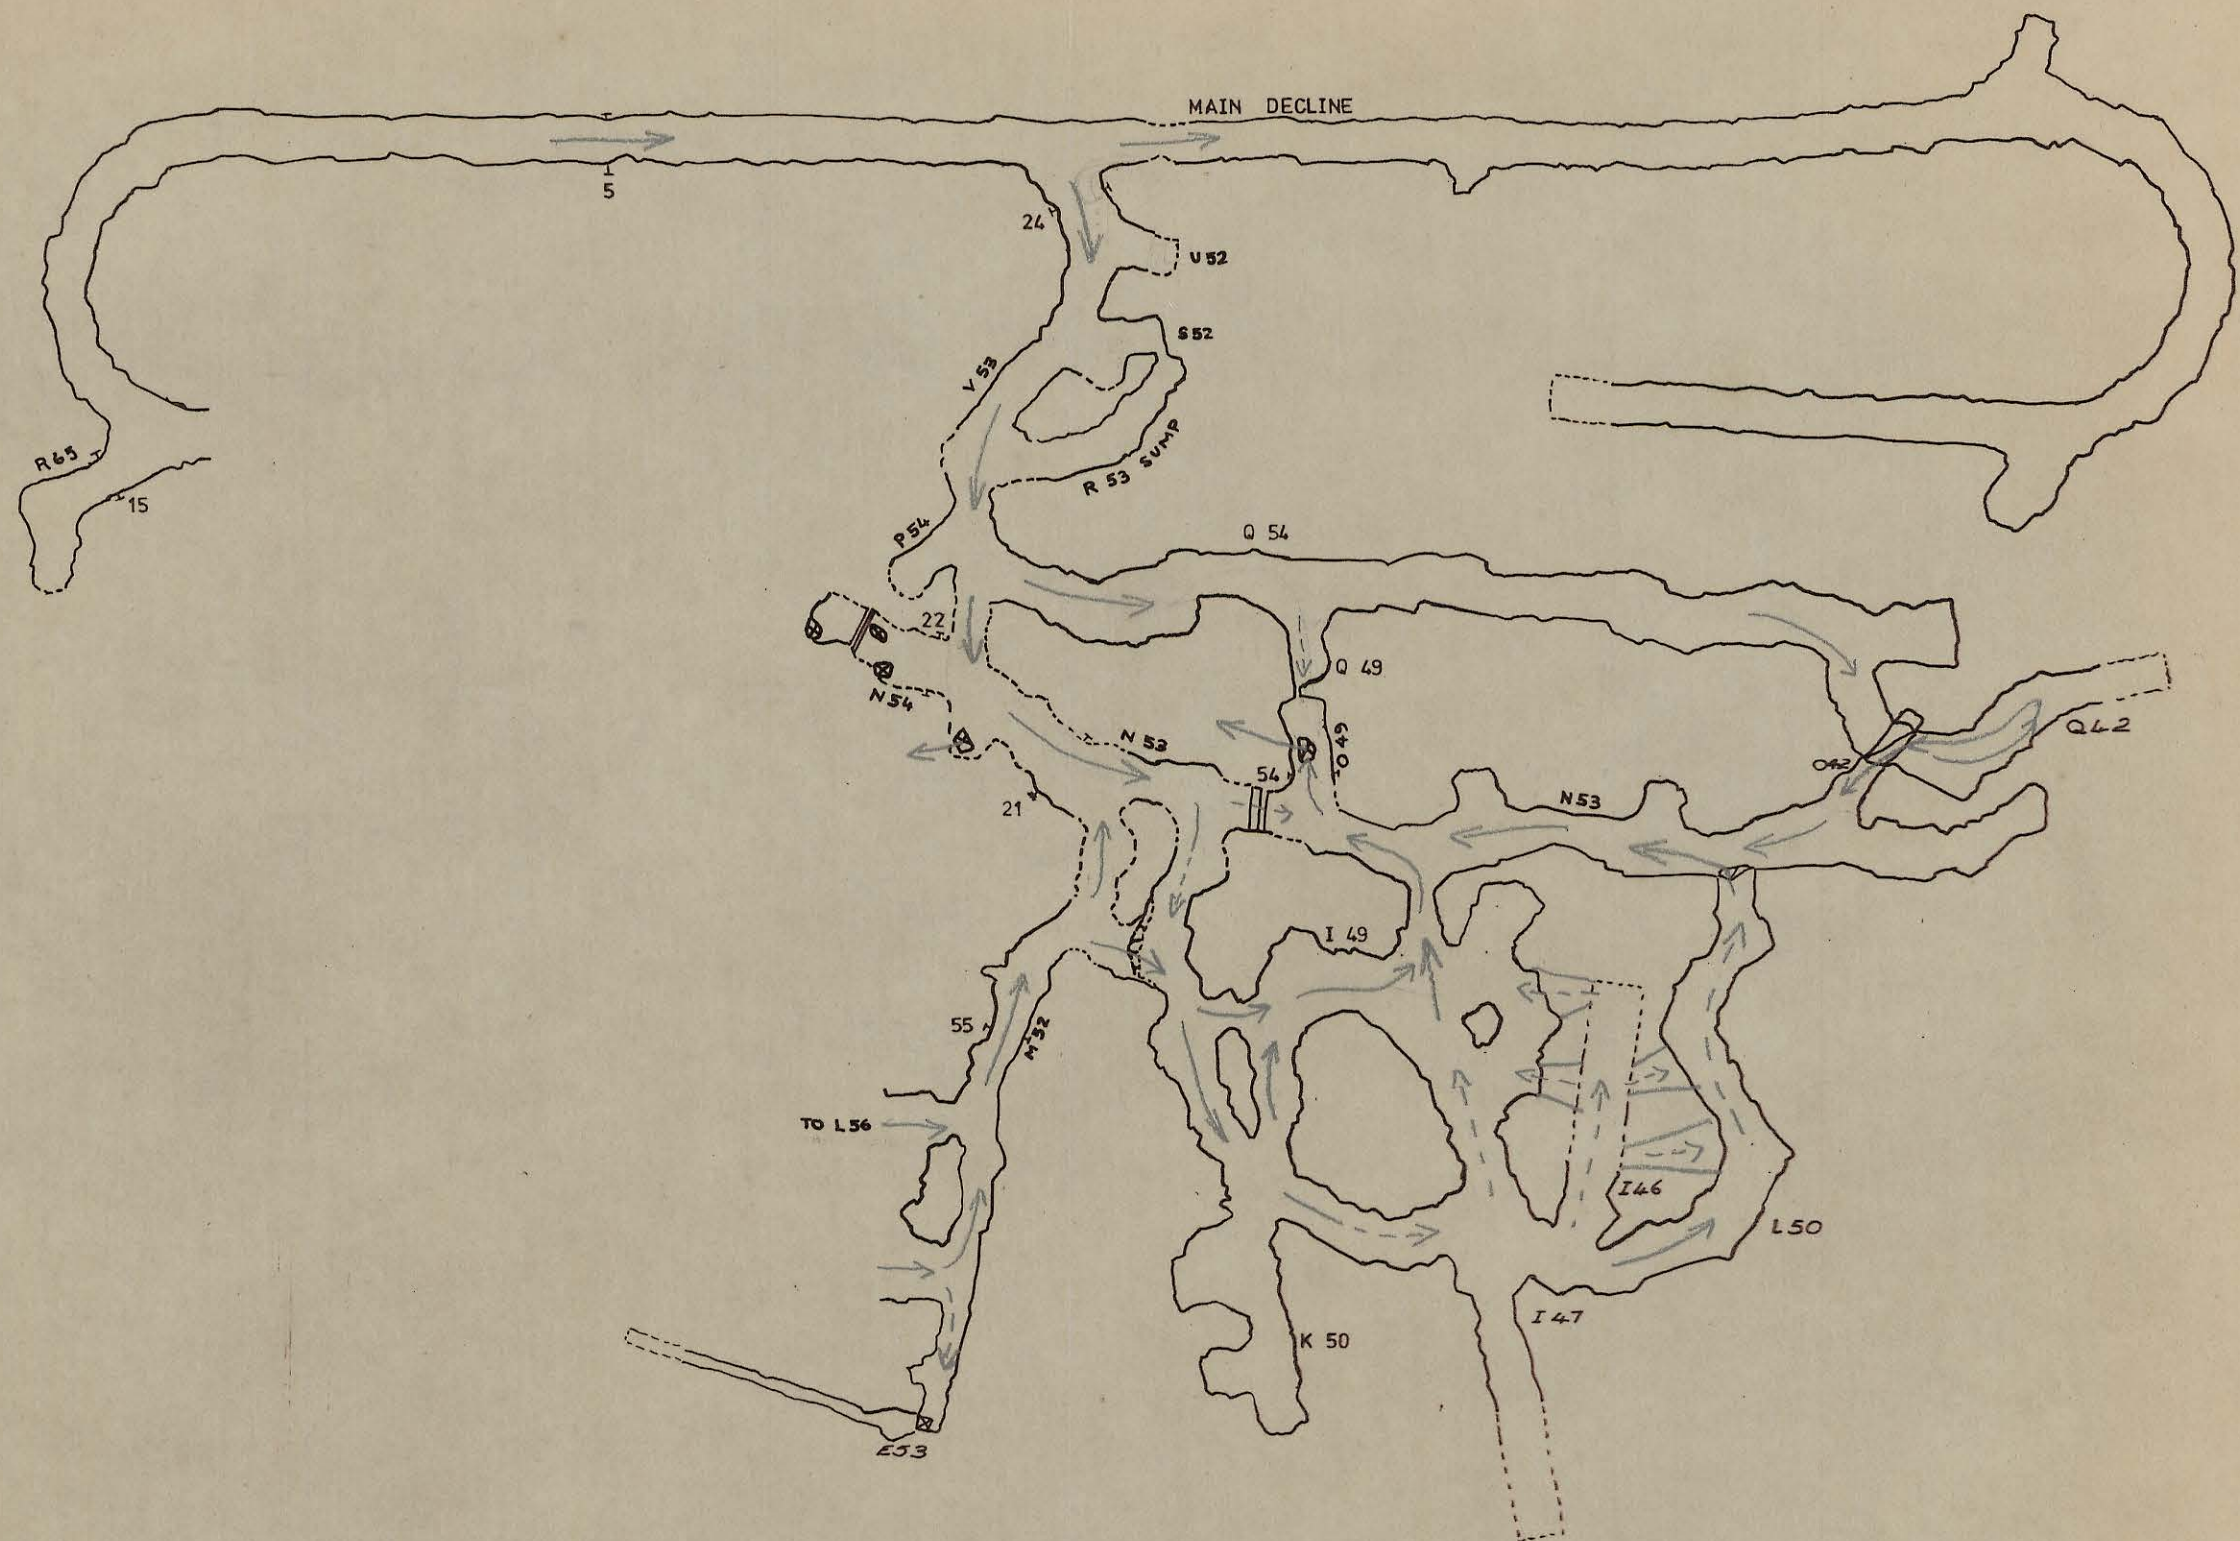

	KING ISLAND SCHEELITE LTD.	
	SCALE 1:1000	05BH05 3036
	BOLD HEAD MINE	
	B LENS FAULT BLOCK	
	VENTILATION PLAN SMOKE TUBE SURVEY 3-6-77	
DATE		
SURVEYED		
DRAWN		
TRACED		
CHECKED		