


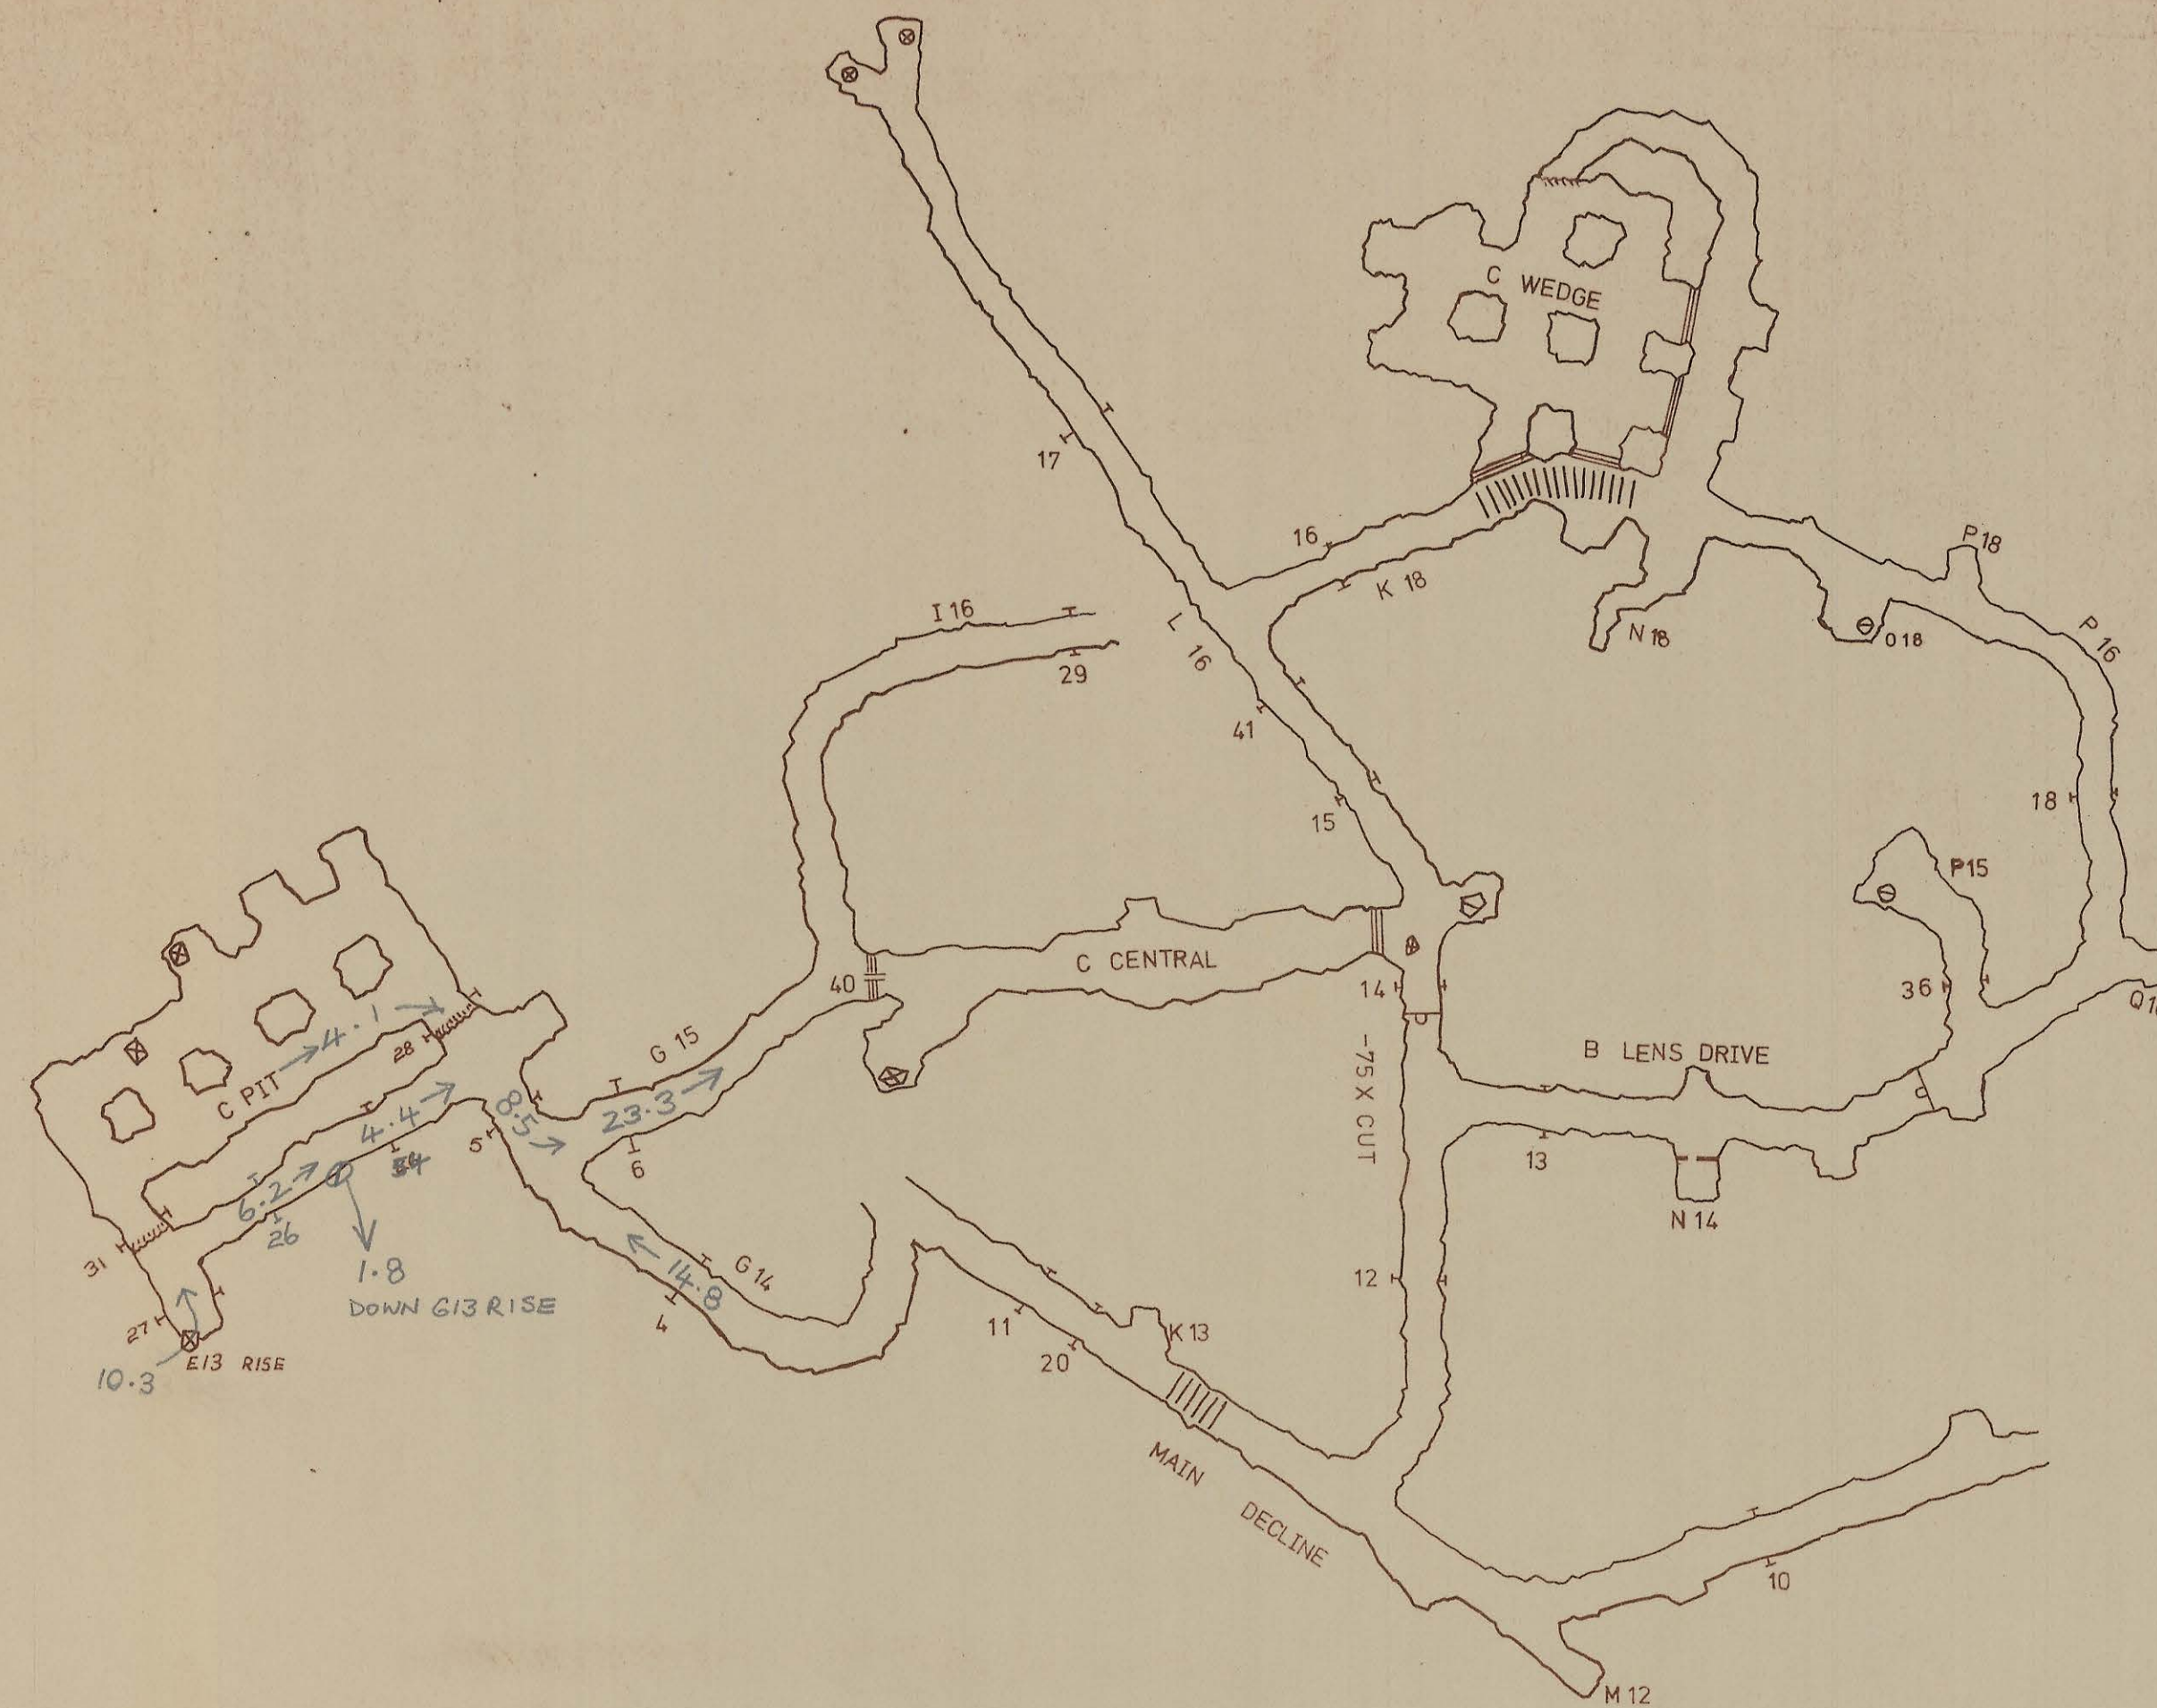

SCALE 1" = 100'

VENTILATION SURVEY

1-3-77

VOLUMES IN M³/S

DOLPHIN MINE

- 75 m ZONE

VENTILATION PLAN

north

KIS KING ISLAND SCHEELITE

GRASSY KING ISLAND

PLAN NUMBER 05DM05 2028

5 cm

0374_3551

05DM05 2028