


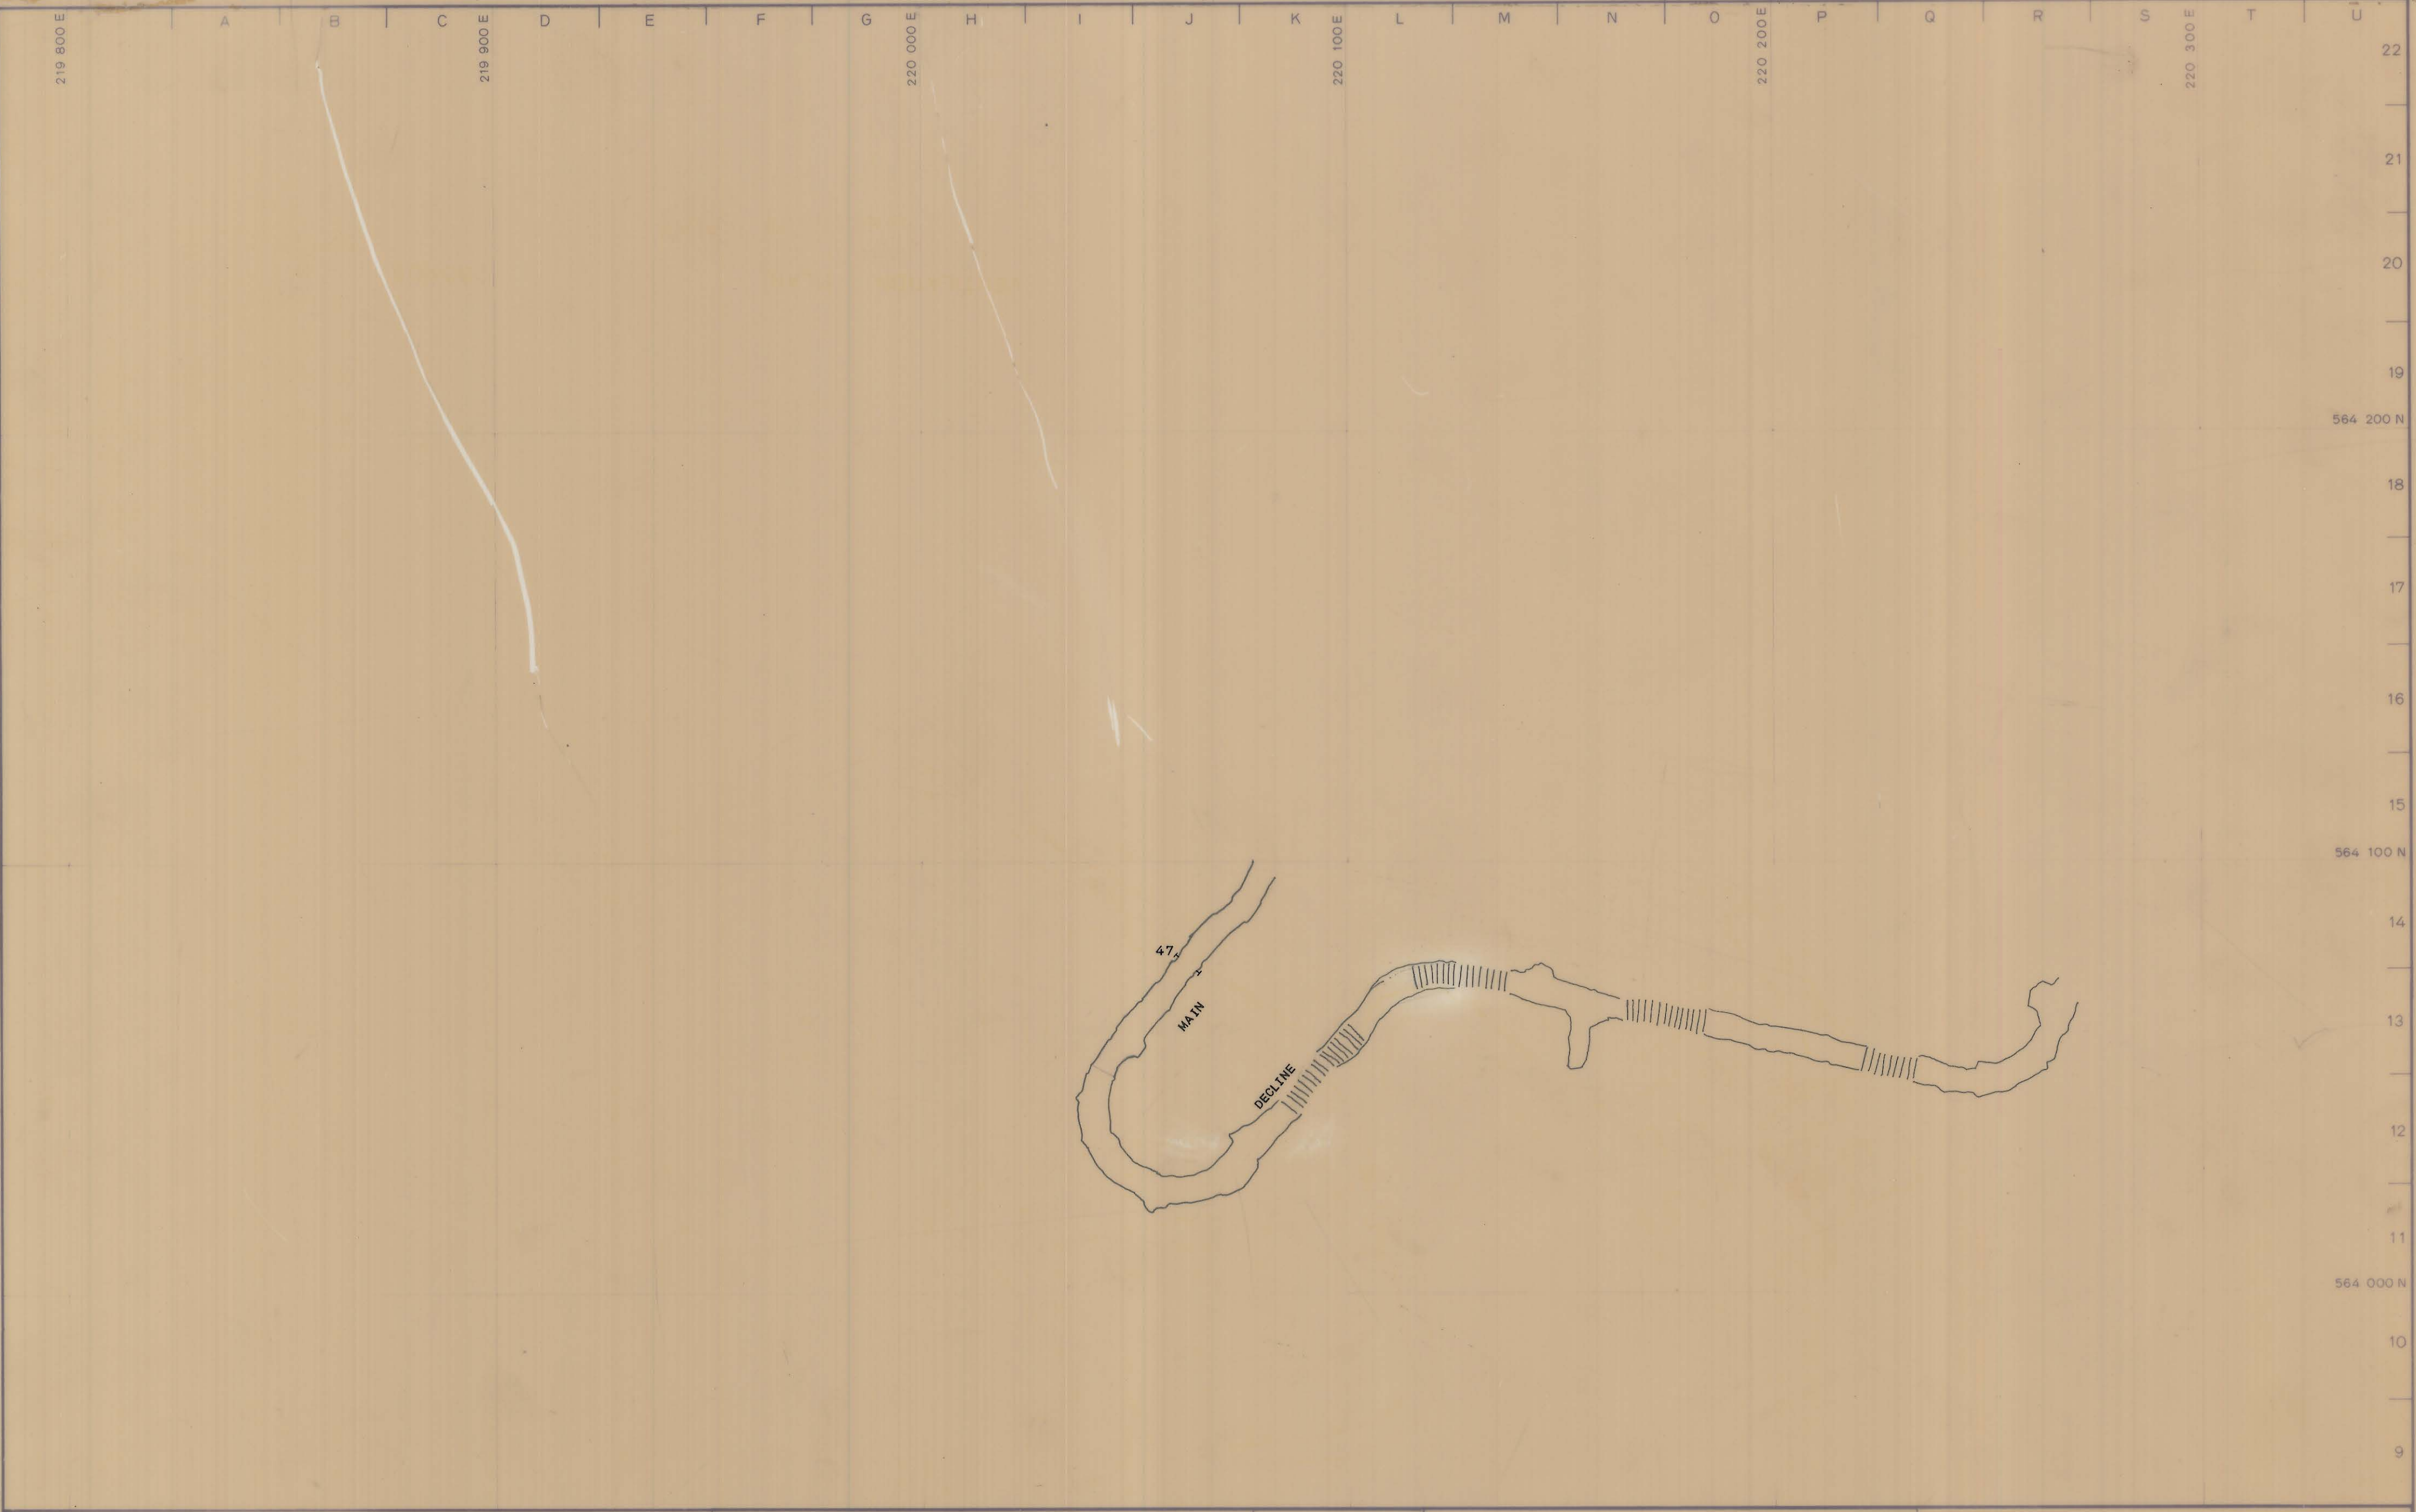

	SCALE 1: 1000	 north	LOCATION DOLPHIN MINE	 GRASSY KING ISLAND	
			SUBJECT - 175 m ZONE VENTILATION PLAN		PLAN NUMBER 05 DM 05 2 089

27 JUN 1981

0374_3568

5 cm

05DM05-2039